
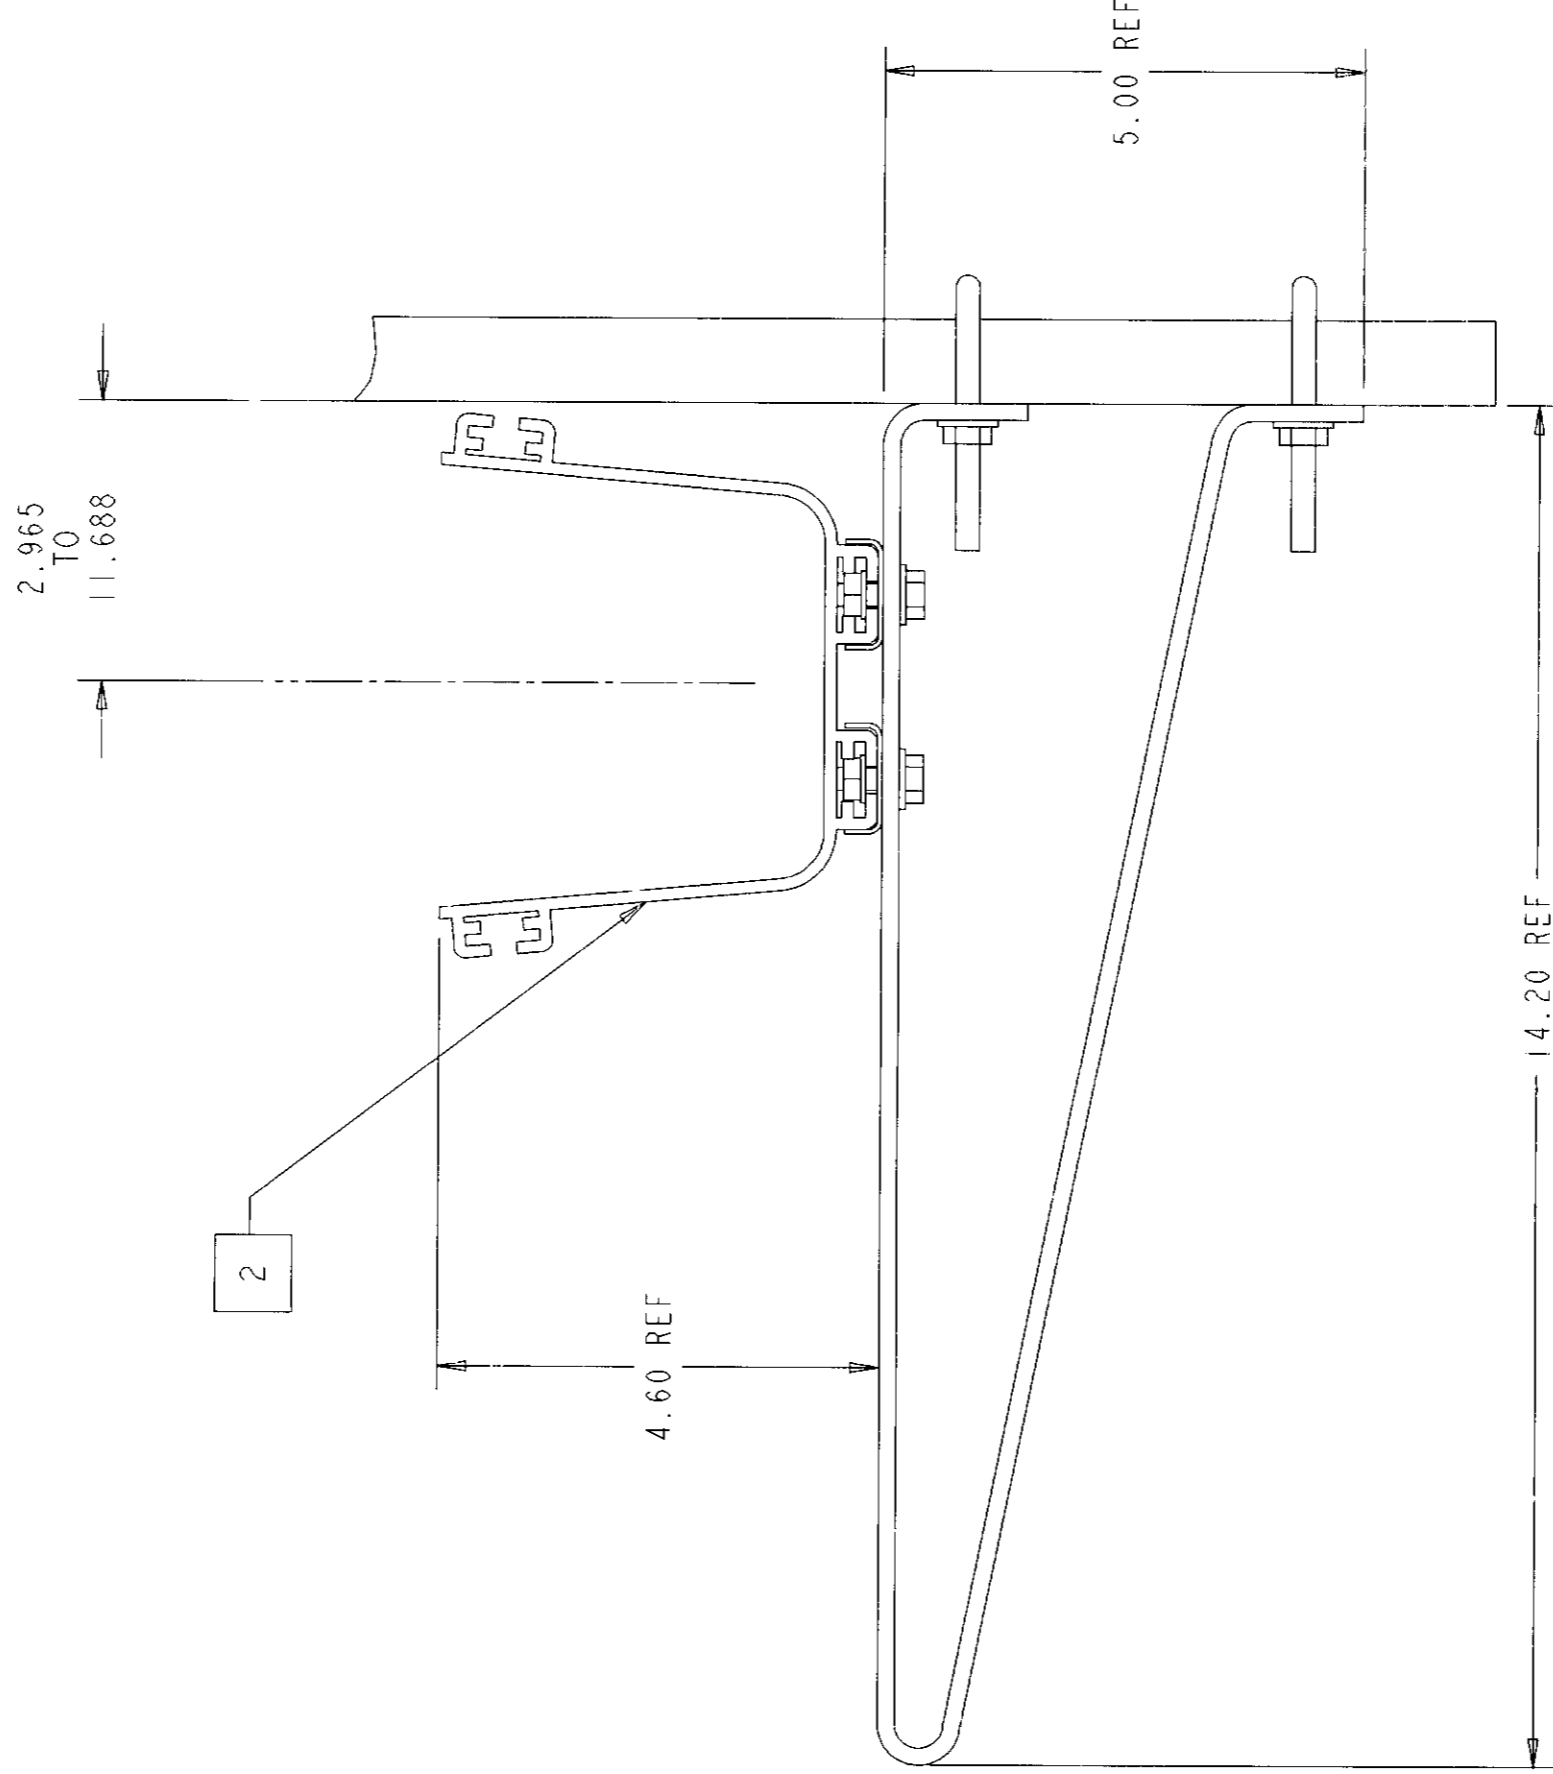
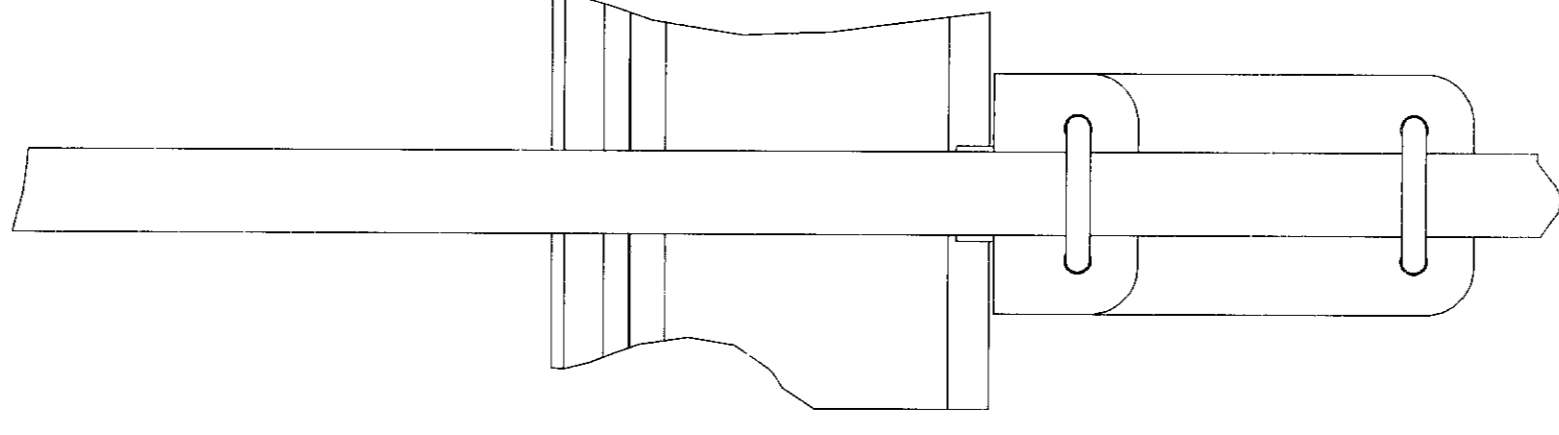


REV	ECO	DWN	DATE
A	67387	DDC	12-18-90
B	97847	MV	08-17-92

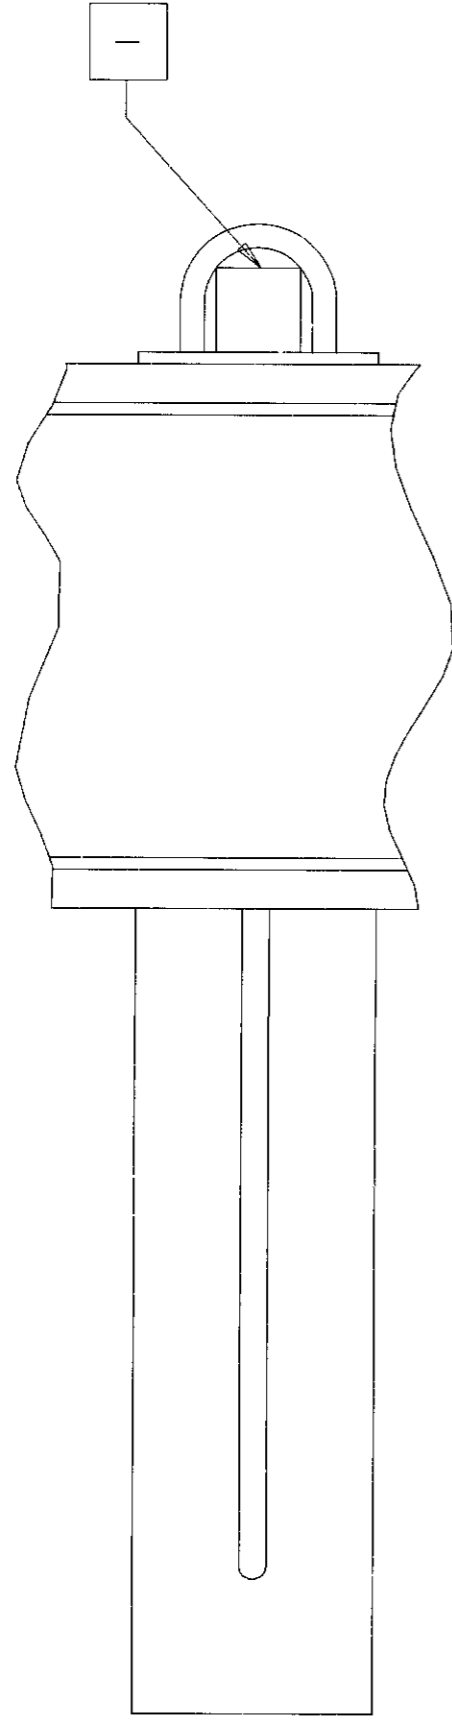


2 FIBERGUIDE FGS-MSHS-A (NOT INCLUDED IN KIT).

1 SUPPORT PEDESTAL NOT INCLUDED. WILL FIT .625 TO 1.20 ROUND OR SQUARE POST.

NOTES:

CATALOG NUMBER: FGS-HUFB-A

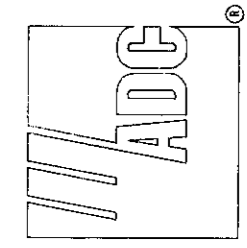

INFORMATION ON THIS DOCUMENT IS PROPRIETARY TO ADC AND SHALL NOT BE USED, COPIED, REPRODUCED OR DISCLOSED IN WHOLE OR IN PART WITHOUT WRITTEN CONSENT OF ADC.		TITLE FIBERGUIDES 4" UNDERFLOOR BRACKET INSTALLATION DRAWING	
TOLERANCE UNLESS OTHERWISE SPECIFIED:	XX: REF	C DRAWING NUMBER	B REV
ANGULAR:	XX: REF	SIZE 4-29000-3291	
DO NOT SCALE DRAWING	ENGR: R. HENNEBERGER	SHT. 1 OF 1	
	DWN: D. CARPENTER		

A

B

C

D